

AREA 1



ARCADIS

LEGAL ENTITY:
ARCADIS U.S., INC.

CONSULTANTS



OHM ADVISORS
560 NORTH FOURTH STREET, SUITE 610
COLUMBUS, OH 43215

SEALS

CITY OF NEWARK,
OHIO

FOURTH STREET
COMBINED SEWER
SEPARATION
PROJECT

NO.	DATE	ISSUED FOR	BY

COPYRIGHT: ARCADIS, INC. 2019
DATE: JANUARY 2020
PROJECT NO.: 00821277.0002
FILE NAME: 00000_GB001
DESIGNED BY: _____
DRAWN BY: _____
CHECKED BY: _____

SHEET TITLE

SCHEMATIC PLAN

ISSUE STATUS:
CTC SET

SCALE: 0 200 400
100

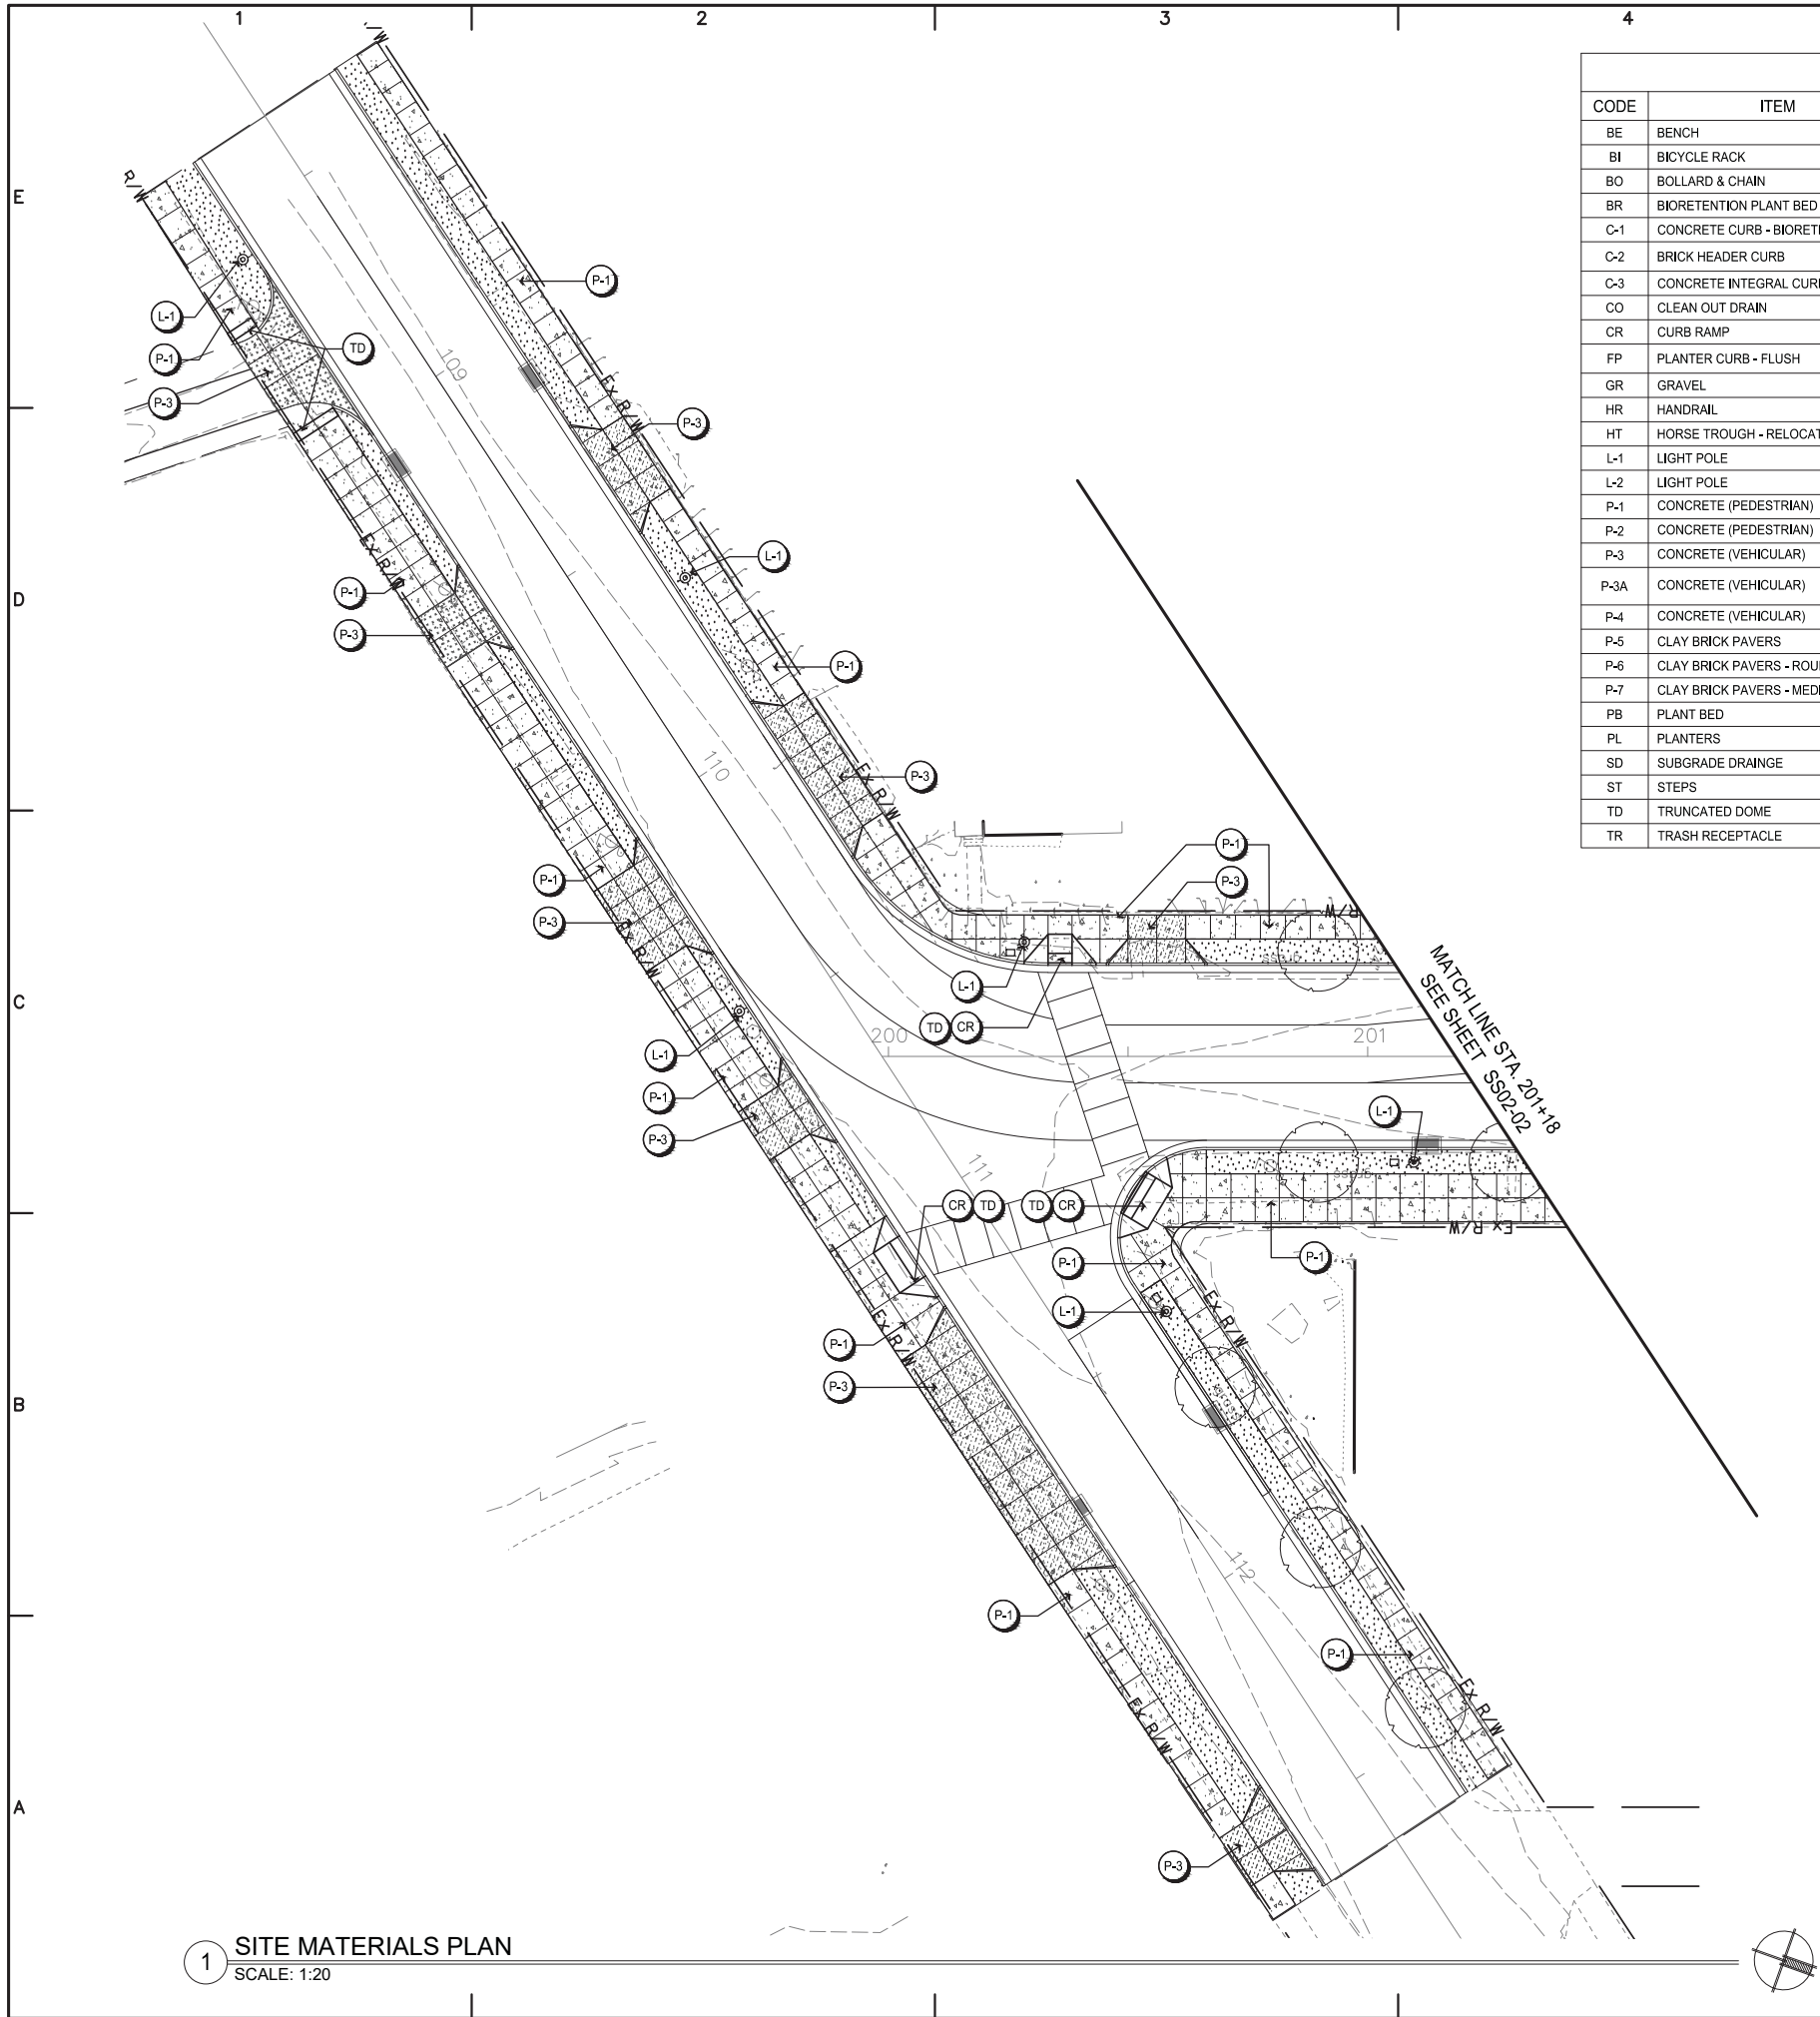
SHEET NO.:
T00-01

NOTE:

SEE PLAN AND PROFILE SHEETS FOR SURVEY CONTROL INFORMATION.

User:BCAN Spec:AUS-NCMOD File:P:\7201_7300\7282\80010_NEWARK_4TH_ST\DESIGN\ROADWAY\SHEETS\00000_GB001.DGN Scale:1:**** SavedDate:1/13/2020 Time:11:41 Plot Date: Bremen Cdn: 2/7/2017 19:21 : Layout:MODEL

 
 
 
 
User: AHERRON Spec: AUS-NCSMOD File P:\7201_7300\7282180010_NEWARK_4TH_STREET\PLN_UD\DRAWINGS\SHEETS\180010_MATR_01.DWG Scale: 1:1 Saved Date: 1/16/2020 Time: 14:19 Plot Date: Anne Herron; 1/20/2020; 10:12; Layout: 1

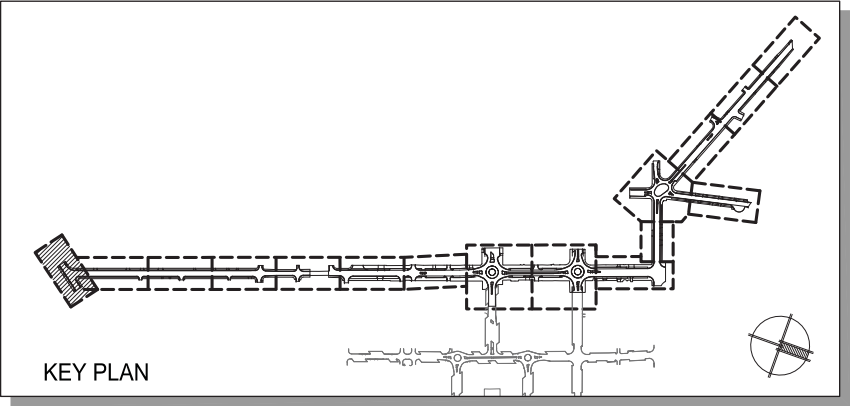


1 SITE MATERIALS PLAN
SCALE: 1:20

MATERIALS LIST				
CODE	ITEM	FINISH	SIZE	NOTES
BE	BENCH	DUMOR - BENCH 162	PER PLAN	SEE SHEET SS00-04/DETAIL 6
BI	BICYCLE RACK	ANOVA - LBR2PSURF U BIKE RACK - BLACK	PER PLAN	SEE SHEET SS00-04/DETAIL 7
BO	BOLLARD & CHAIN	NEENAH FOUNDRY, R-8401-43BB	PER PLAN	SEE SHEET SS00-04/DETAIL 4&5
BR	BIORETENTION PLANT BED	-	PER PLAN	SEE SHEET SS00-08 AND SS00-05/DETAILS 1 & 2
C-1	CONCRETE CURB - BIORETENTION	BROOM FINISH	PER PLAN	SEE SHEET SS00-03/DETAIL 9
C-2	BRICK HEADER CURB	BROOM FINISH	PER PLAN	SEE SHEET SS00-03/DETAIL 10
C-3	CONCRETE INTEGRAL CURB	BROOM FINISH	PER PLAN	SEE SHEET SS00-03/DETAIL 11
CO	CLEAN OUT DRAIN	-	PER PLAN	SEE SHEET SS00-08
CR	CURB RAMP	SEE ROADWAY DRAWINGS	PER PLAN	
FP	PLANTER CURB - FLUSH	CONCRETE, BROOM FINISH	6'X15'	SEE SHEET SS00-06
GR	GRAVEL	TEMPORARY GRAVEL WALK	PER PLAN	-
HR	HANDRAIL	ALUMINUM PIPE RAIL	PER PLAN	SEE SHEET SS00-09/DETAILS 1 & 2
HT	HORSE TROUGH - RELOCATED	6" GRAVEL BASE	PER PLAN	-
L-1	LIGHT POLE	GRANVILLE LED, BLACK	12' POLE HGT.	SEE ELECTRICAL DRAWINGS
L-2	LIGHT POLE	TWIN GRANVILLE LED, BLACK	16' POLE HGT.	SEE ELECTRICAL DRAWINGS
P-1	CONCRETE (PEDESTRIAN)	BROOM FINISH, 4" DEPTH	PER PLAN	SEE SHEET SS00-03/DETAIL 1 & 5
P-2	CONCRETE (PEDESTRIAN)	EXPOSED AGGREGATE, 4" DEPTH	PER PLAN	SEE SHEET SS00-03/DETAIL 1 & 5
P-3	CONCRETE (VEHICULAR)	BROOM FINISH, 6" DEPTH	PER PLAN	SEE SHEET SS00-03/DETAIL 2 & 5
P-3A	CONCRETE (VEHICULAR)	BROOM FINISH, 7" DEPTH	PER PLAN	ITEM 451 - 7" REINFORCED CON. PAVEMENT CLASS QC1P; 6" AGGREGATE 304
P-4	CONCRETE (VEHICULAR)	EXPOSED AGGREGATE	PER PLAN	SEE SHEET SS00-03/DETAIL 2 & 5
P-5	CLAY BRICK PAVERS	BELDON - 560	STANDARD	SEE SHEET SS00-03/DETAIL 3 AND SHEET SS00-07
P-6	CLAY BRICK PAVERS - ROUNDABOUTS	REPURPOSED BRICK, CONTACT CITY OF NEWARK	STANDARD	SEE SHEET SS00-03/DETAIL 4 AND SHEET SS00-07
P-7	CLAY BRICK PAVERS - MEDIAN	PINEHALL - IRON SPOT - VEHICULAR	STANDARD	SEE SHEET SS00-03/DETAIL 4 AND SHEET SS00-07
PB	PLANT BED	SEE PLANTING PLANS	PER PLAN	SEE PLANTING DETAIL SHEET SS00-10
PL	PLANTERS	LANDSCAPEFORMS - ROSA - POWDER COATED BLACK	PER PLAN	SEE SHEET SS00-04/DETAIL 3
SD	SUBGRADE DRAINAGE	-	PER PLAN	SEE SHEET SS00-08
ST	STEPS	-	PER PLAN	SEE SHEET SS00-08
TD	TRUNCATED DOME	ENDICOTT TRUNCATED DOME 4X8 PAVERS	PER PLAN	SEE MATERIAL PLANS AND SPECIFICATIONS
TR	TRASH RECEPTACLE	MATCH EXISTING	PER PLAN	

MATERIALS LEGEND:

-  PROPOSED DECIDUOUS TREE
-  PROPOSED FLUSH PLANTER
-  PROPOSED LIGHT POLE
-  PROPOSED LAWN
-  PROPOSED CONCRETE PAVEMENT - PEDESTRIAN
-  PROPOSED CONCRETE PAVEMENT - VEHICULAR
-  GRAVEL - TEMPORARY



KEY PLAN



LEGAL ENTITY:
ARCADIS U.S., INC.

CONSULTANTS



580 NORTH FOURTH STREET, SUITE 610
COLUMBUS, OH 43215

SEALS



CITY OF NEWARK
DIVISION OF WATER AND WASTEWATER

FOURTH STREET
COMBINED SEWER
SEPARATION
PROJECT

NO.	DATE	ISSUED FOR	BY

COPYRIGHT: ARCADIS, INC. 2019
DATE: JANUARY 2020
PROJECT NO.: 00821277.0002
FILE NAME: 180010_MATR_01
DESIGNED BY: JH
DRAWN BY: AH
CHECKED BY: JM

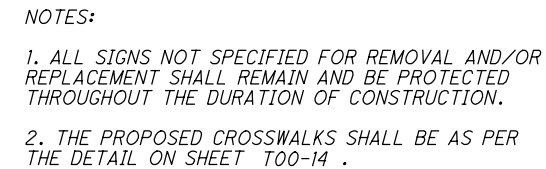
SHEET TITLE

AREA 01
MATERIALS PLAN

ISSUE STATUS: CTC SET

SCALE: GRAPHIC SCALE: 1 inch = 20 feet
0 10 20 40

SHEET NO.:
SS01-02

TRAFFIC CONTROL LEGEND